



# ANNEXURE C FLOOR PLAN

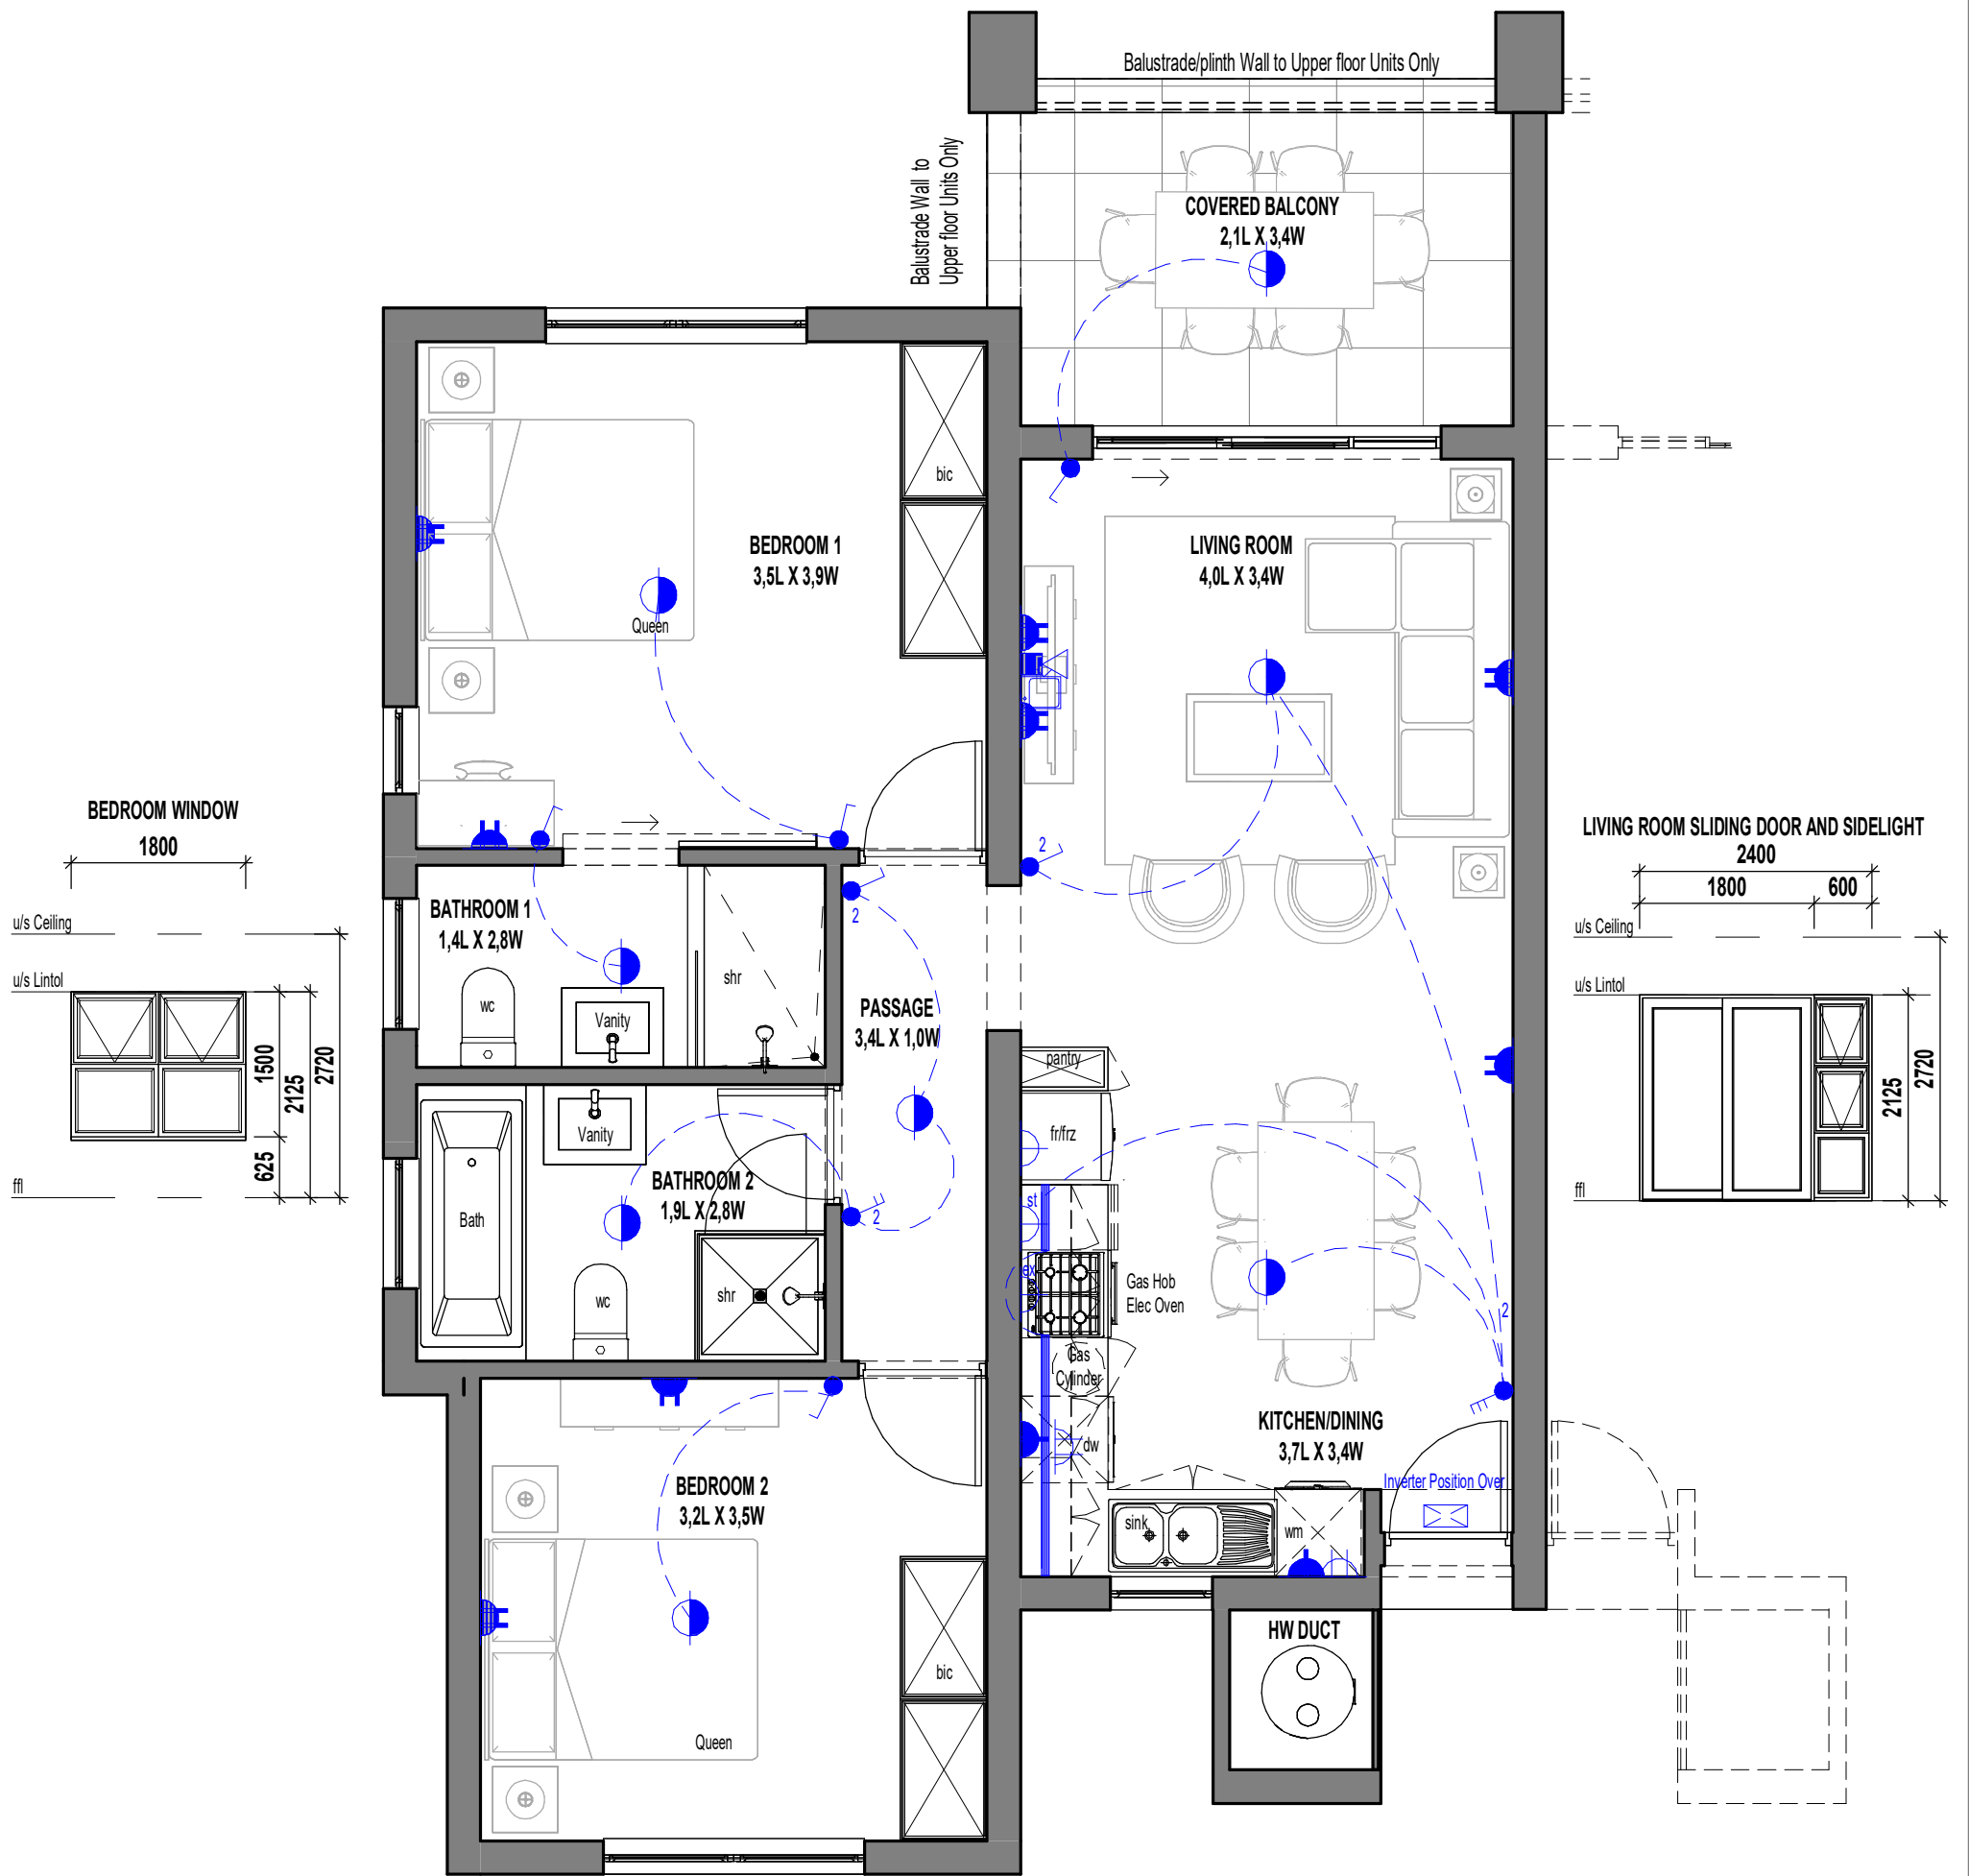

2 Bedroom - 2 Bathroom

SCALE 1:50

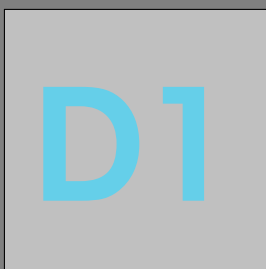

### ELECTRICAL LEGEND

- |  |                                                      |  |                                         |  |                    |
|--|------------------------------------------------------|--|-----------------------------------------|--|--------------------|
|  | Surface Mounted LED Fitting                          |  | Single Plug Point (300mm Above FFL)     |  | Distribution Board |
|  | External Wall Mounted LED Light Fitting              |  | Double Plug Point (300mm Above FFL)     |  | TV Point           |
|  | LED Strip Light Fitting (u/s - Eye levels - Kitchen) |  | Single Plug Point (150mm Above Counter) |  | Fibre / Data Point |
|  | Single Light Switch                                  |  | Double Plug Point (150mm Above Counter) |  | Inverter           |
|  | Double Light Switch                                  |  | Stove Isolator (Above Counter)          |  |                    |
|  | Triple Light Switch                                  |  | Extractor Plug (High Level)             |  |                    |
|  | Two-Way Light Switch                                 |  |                                         |  |                    |

### AREA TYPE D1

Floor Area	74.37 m <sup>2</sup>
Cov Patio/Balcony	8.74 m <sup>2</sup>
Total	83.11 m <sup>2</sup>

\* The areas are approximate and shall vary from the areas reflected on the sectional title plan